




FIXTURE SCHEDULE

MOUNTING LEGEND:
R - RECESSED, S - SURFACE, P-PENDANT, C-CEILING


1. NEW HAND DRYER (HD) TO BE HARDWARED, CONNECT TO CIRCUIT SHOWN, MOUNT AT 54" AFF TO CENTER OF UNIT. HD TYPE TO BE SELECTED BY ARCHITECT.
2. PROVIDE UNDERGROUND FEEDER 24" BELOW GROUND (SIZE AS SHOWN) TO EXISTING PANEL APPROXIMATELY 65FT AWAY. REFER TO SHEET "C3" FOR LOCATION. CONNECTED TO EXISTING 100A 2P CIRCUIT BREAKER IN EXISTING OUTDOOR PANEL.
3. CONNECT OUTDOOR/BUILDING LIGHTS THROUGH PHOTOCELL SWITCH TO BE MOUNTED ON BUILDING DIRECTED NORTH. VERIFY MOUNTING HEIGHT WITH ARCHITECTURAL PLANS PRIOR TO ROUGH-IN.

1. ELECTRICAL WORK SHALL COMPLY WITH LATEST NATIONAL ELECTRICAL CODE, LIFE SAFETY CODE AND APPLICABLE STATE AND LOCAL CODES AND ORDINANCES.
2. ELECTRICAL EQUIPMENT AND WIRING SHALL BE NEW AND SHALL BE FURNISHED AND INSTALLED BY THIS CONTRACTOR, UNLESS OTHERWISE NOTED.
3. WIRING SHALL BE IN CONDUIT. CONDUIT SHALL BE 3/4" MIN. CONDUITS IN FINISHED AREAS SHALL BE CONCEALED. CONTRACTOR MAY USE SURFACE RACE AND FITTINGS FOR WIRING IN FINISHED AREAS WHERE CONDUITS CAN NOT BE CONCEALED, ONLY WITH PRIOR APPROVAL FROM DESIGN PROFESSIONAL.
4. NEW WIRES SHALL BE TYPE THHN. MINIMUM SIZE SHALL BE #12 AWG, UNLESS OTHERWISE NOTED.
5. RECEPTACLE CIRCUITS SHALL HAVE A DEDICATED GROUND AND DEDICATED NEUTRAL.
6. NO METAL CLAD FLEXIBLE WIRING SHALL BE USED EXCEPT FROM JUNCTION BOX TO FIXTURES AND SHALL NOT EXCEED 6 FEET IN LENGTH.
7. FINAL CONNECTIONS TO EQUIPMENT, FURNISHED AND INSTALLED BY OTHERS, SHALL BE PROVIDED BY THIS CONTRACTOR.
8. VERIFY LOCATION OF LIGHTING FIXTURES, MECHANICAL EQUIPMENT IN CEILING, AND POWER OUTLETS ETC. WITH DESIGN PROFESSIONAL PRIOR TO ROUGH-IN.
9. VERIFY AND COORDINATE WITH ARCHITECTURAL DRAWINGS EXACT LOCATION AND MOUNTING HEIGHTS OF POWER AND DATA OUTLETS.
10. CIRCUIT BREAKER ARRANGEMENT INDICATED ON THE ELECTRICAL RISER DIAGRAM DOES NOT NECESSARILY CORRESPOND TO THE ACTUAL BREAKER ARRANGEMENT OR PANEL PHASING. IT IS THE RESPONSIBILITY OF THE ELECTRICAL CONTRACTOR TO BALANCE THE LOADS ON THE PANEL AT THE TIME OF INSTALLATION. EVERY ATTEMPT MUST BE MADE TO GROUP SIMILAR LOADS AND LOCATE ALL SPARES AND SPACES AT THE BOTTOM OF THE PANEL.
11. PROVIDE A TYPEWRITTEN DIRECTORY IN THE PANEL DOOR, ACCURATELY INDICATING ROOMS AND EQUIPMENT BEING SERVED. CONTRACTOR SHOULD MAKE EVERY ATTEMPT TO IDENTIFY ALL CIRCUITS.


* Items that are considered continuos (greater than 2 hours)

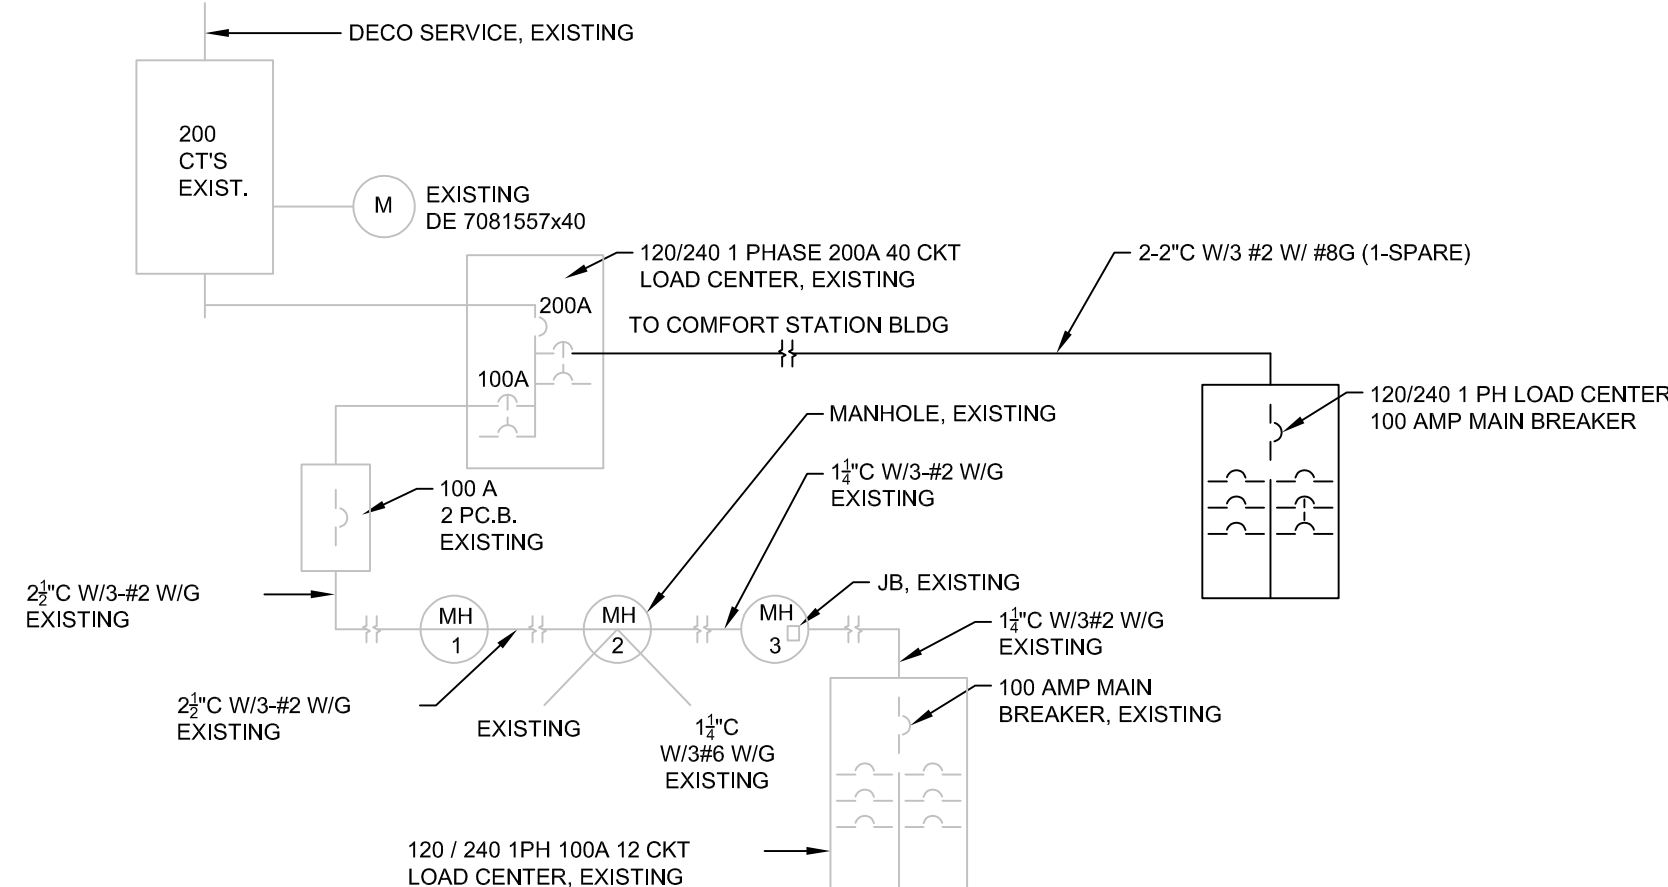

SCALE: N.T.S. EXISTING TO REMAIN U.N.O.

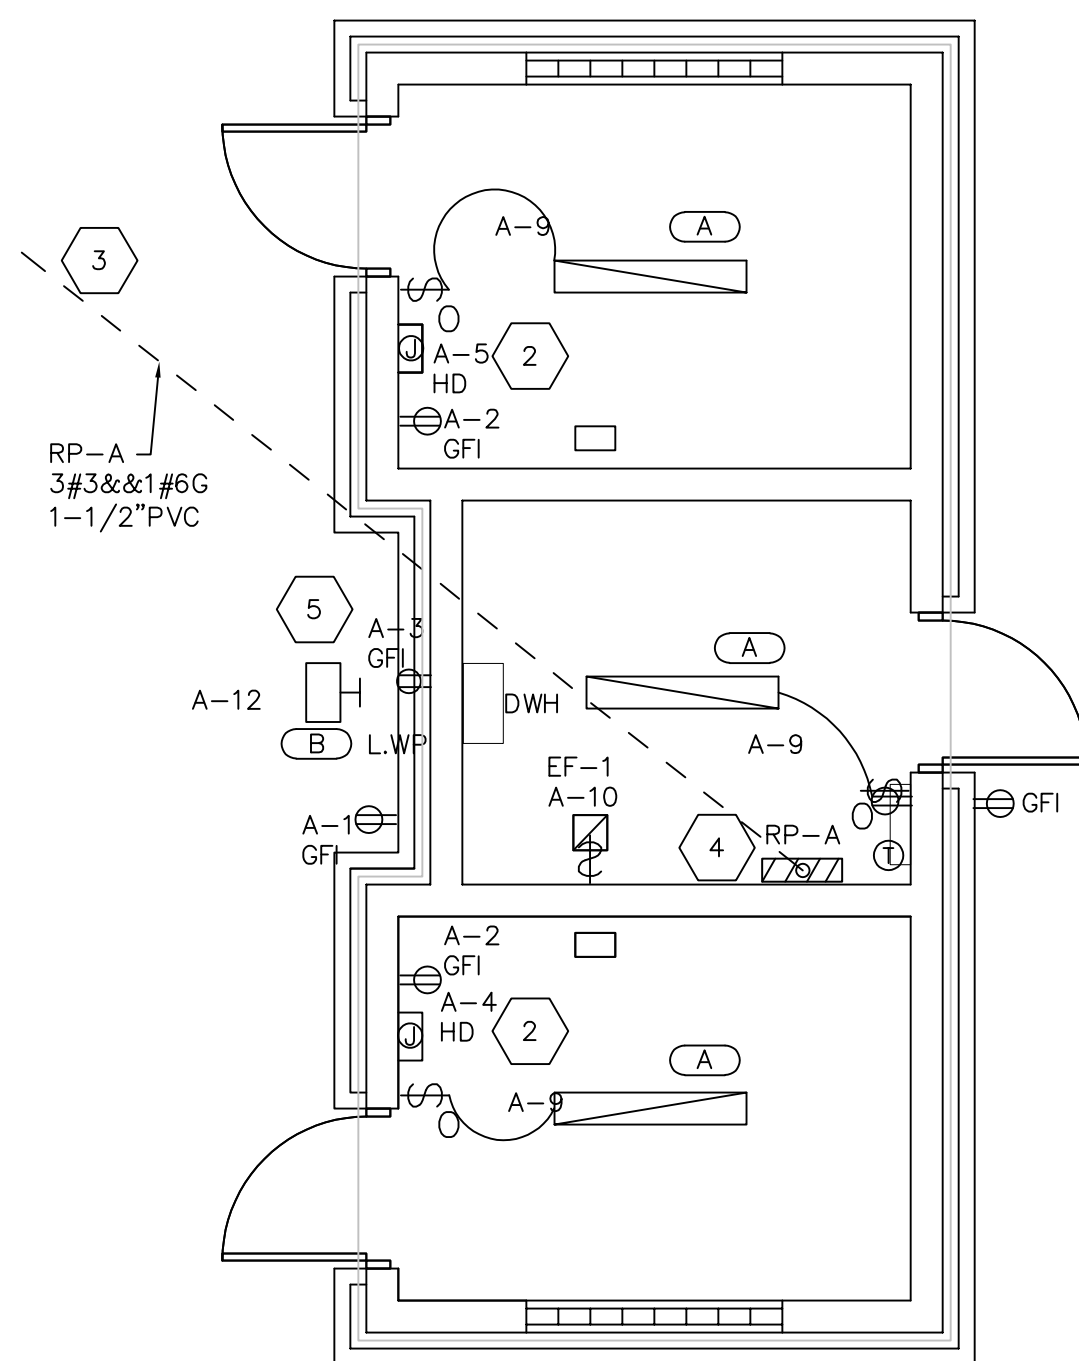

SCALE: 1/4"=1'-0"

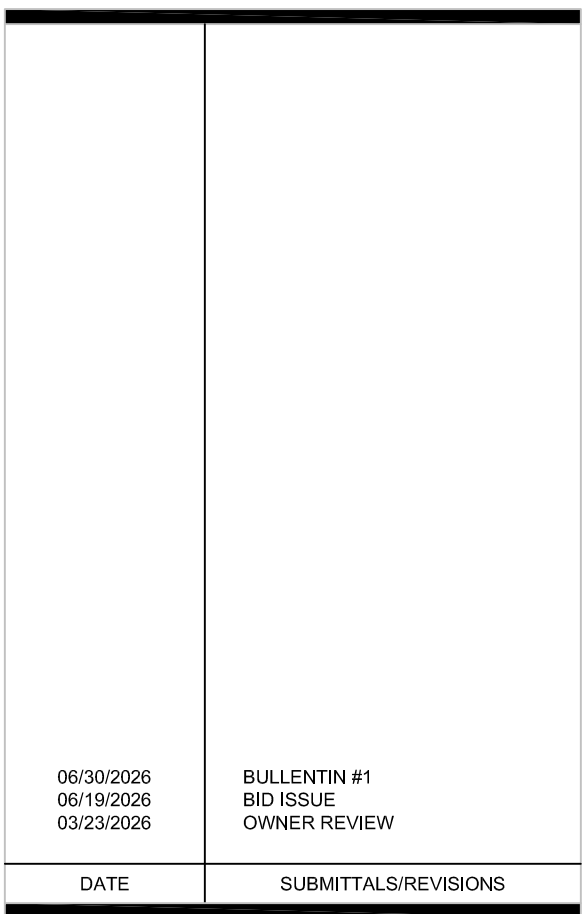

PROJECT NAME:

SHEET TITLE

CLIENT:

ST. CLAIR

☒	PRELIMINARY	☐	CONSTRUCTION	☐	RECORD
DRAWN BY:		CHECKED BY:		DATE:	
SPK		JRA		JUNE 2026	
SCALE:					



Know what's below. Call 800-452-4529. 72 hours before you dig.

UTILITY INFORMATION, AS SHOWN, INDICATES APPROXIMATE LOCATIONS AND TYPES OF EXISTING FACILITIES ONLY, AS DISCLOSED BY RECORDS PROVIDED TO THIS FIRM FROM THE VARIOUS UTILITY COMPANIES. NO GUARANTEE IS GIVEN OR IMPLIED AS TO THE COMPLETENESS OR ACCURACY THEREOF.

PRIOR TO CONSTRUCTION, ALL LOCATIONS AND DEPTHS OF EXISTING OVERHEAD AND UNDERGROUND UTILITIES (IN CONFLICT WITH THE CONSTRUCTION OF THESE PROPOSED IMPROVEMENTS) SHALL BE VERIFIED IN THE FIELD. DURING THE CONSTRUCTION, THE CONTRACTOR SHALL PROTECT AND SUPPORT ALL UTILITIES THAT ARE ENCOUNTERED. (ALL COSTS FOR UTILITY LOCATION, VERIFICATION, SUPPORT AND PROTECTION SHALL BE INCLUDED IN THE PROPOSED PAY ITEM CONFLICTING WITH THAT UTILITY).

DURING CONSTRUCTION, THE CONTRACTOR SHALL USE EXTREME CAUTION WHEN OPERATING NEAR ANY AND ALL OVERHEAD AND / OR BURIED UTILITIES.

PROJECT NO.

0186-0282

M:\0188\0188-0282\CAD\DRAWINGS\CONSTRUCTION\ARCH\ARCHSHEETS_IRRIGATION EQUIPMENT.DWG
E101-6/30/2026 11:01:18 AM

SHEET NO.

E101

COPYRIGHT, 2026, ANDERSON, ECKSTEIN AND WESTRICK, INC.